 


PROVIDE FOR MINIMUM FAN CAPACITY PER ROOM OF 800 CFM (IN WINTER) AND MAXIMUM CAPACITY OF 8000 CFM (IN SUMMER)



NOTE:
ALL EXTERIOR DOORS
TO BE 3'-0" x 6'-8"


SCALE - 1/4" = 1'-0"



SINGLE DECK NURSERY


S.C. '82	EX. 6355	SHEET 1 OF 3
----------	----------	--------------

NOTE:
SELECT TRUSSES TO MEET
LOCAL SNOW LOADS.

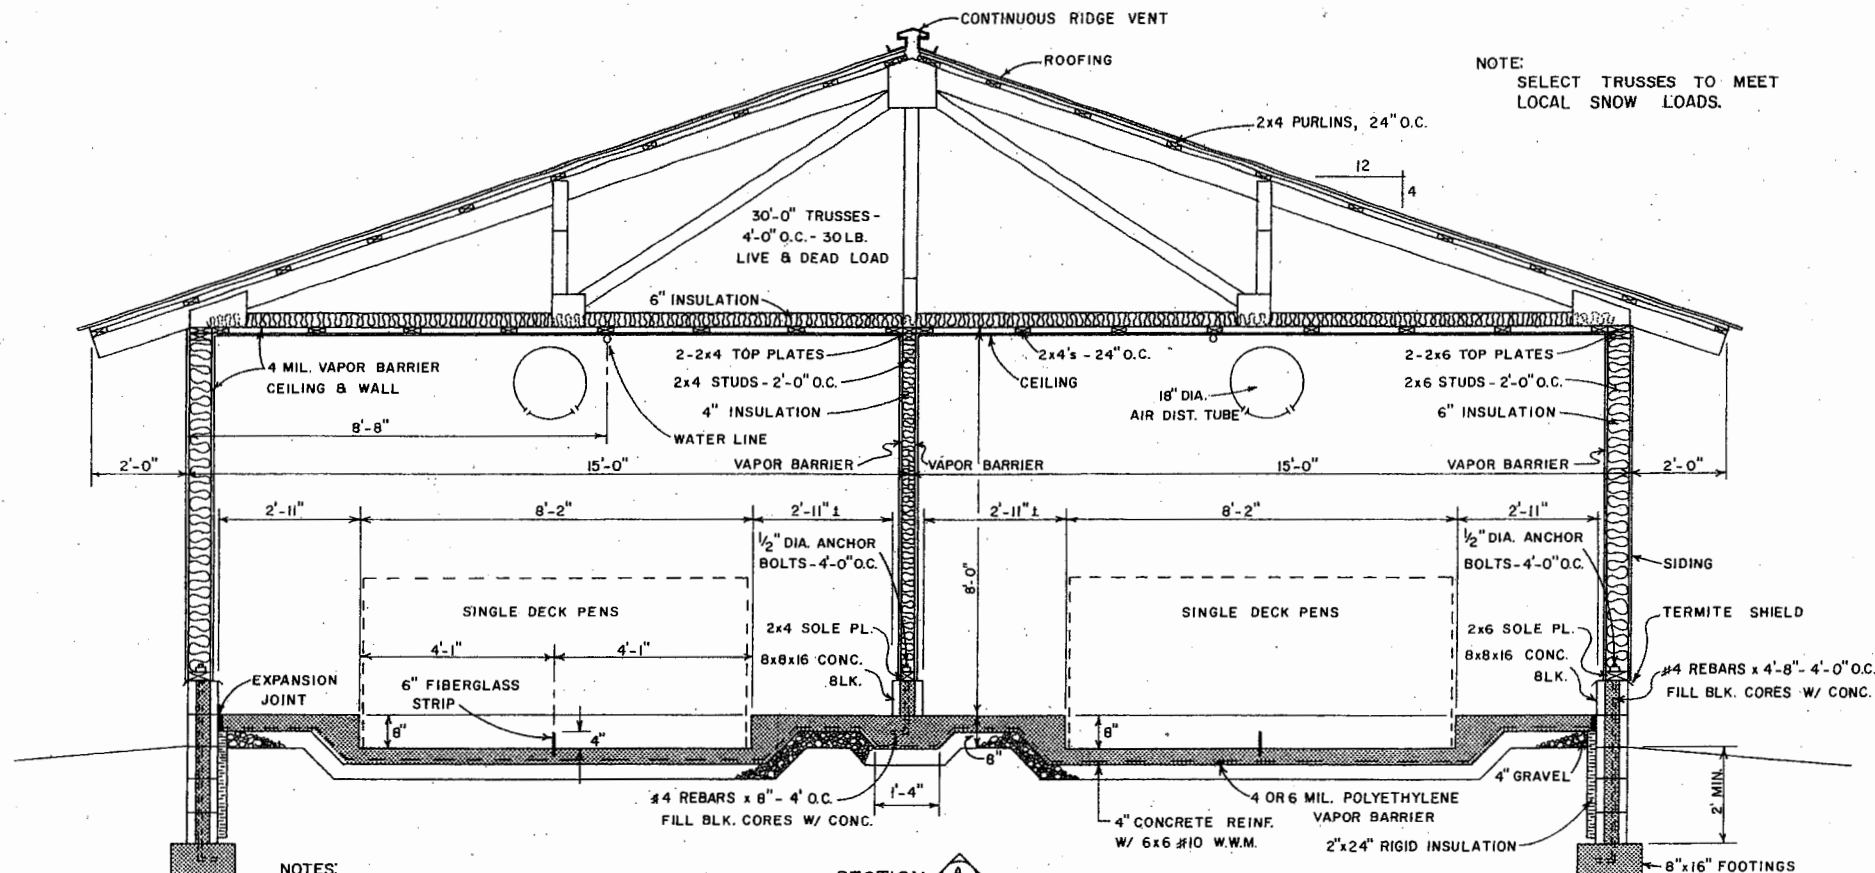


NOTES:
FOOTINGS TO BE BELOW FROST
DEPTH OF AREA WHERE CONSTRUCTED.

 SECTION A-2



SCALE 1/2"=1'-0"

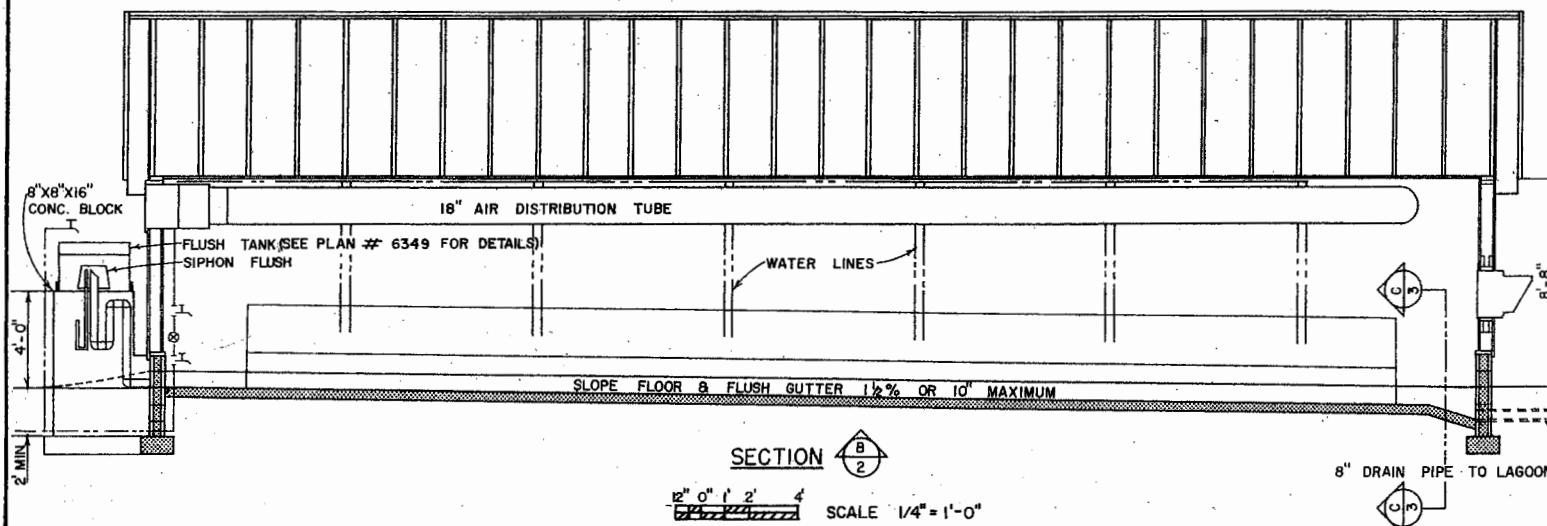


NOTE: ELEVATE BUILDING SO
DRAINAGE GOES TO LAGOON
OR OTHER WASTE TREATMENT
FACILITY BY GRAVITY FLOW.

LSU
AgCenter
Research & Extension

SINGLE DECK NURSERY

SC '82 EX. 6355 SHEET 2 OF 3

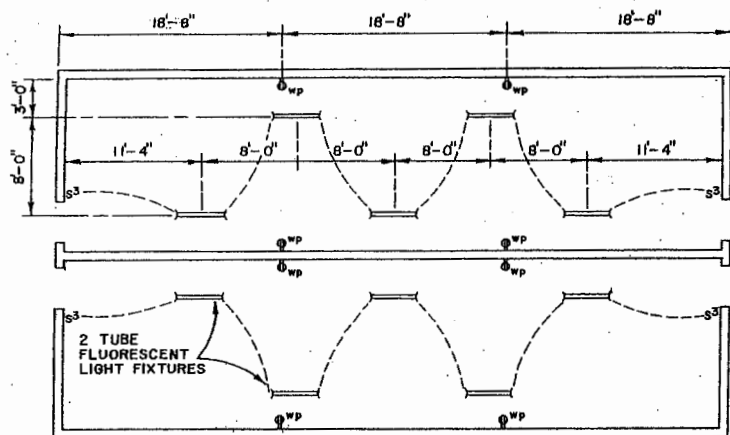


LIGHTING PLAN

12' 0" 1' 4" 11' SCALE 1/8"=1'-0"


NOTE:
ALL LIGHT FIXTURES TO BE
MOISTURE PROOF AND ALL
WIRING TO BE ENCLOSED
IN CONDUIT.

3/4" R.V.C.
WATER LINE

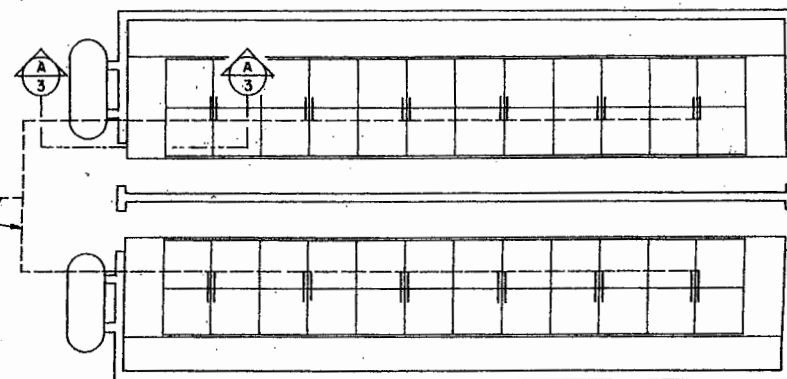


PLUMBING PLAN

12' 0" 1' 4" 11' SCALE 1/8"=1'-0"

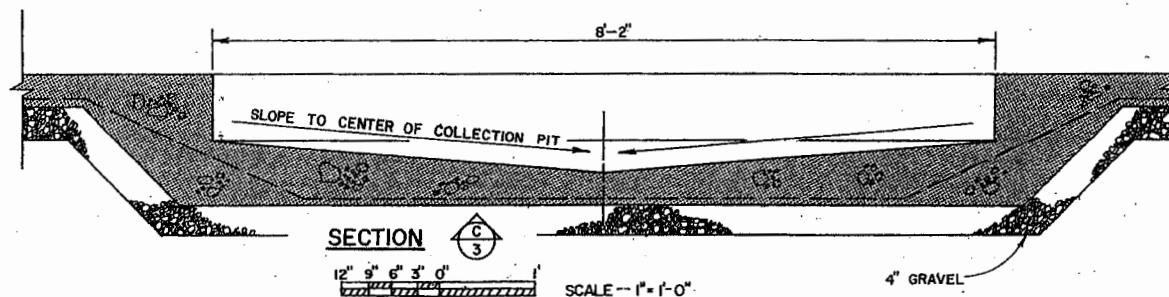

SECTION


12' 9" 6" 3" 0" 1' SCALE 1/8"=1'-0"

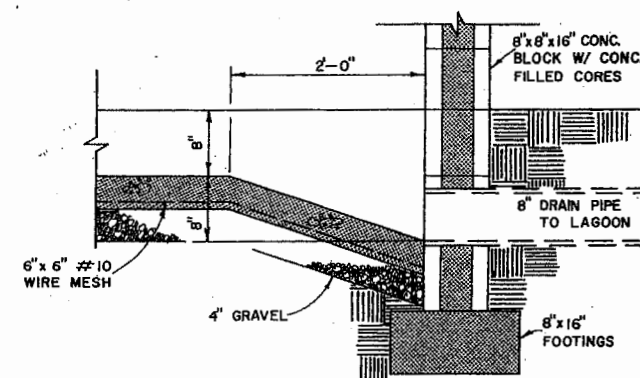

COLLECTION PIT DETAIL

12' 9" 6" 3" 0" 1' SCALE 1/8"=1'-0"

NOTE:
SEE PLAN # 6349 FOR
FLUSH TANK DETAILS.
SUPPORT TANK ON BEAMS
ACROSS CONCRETE BLOCK
STAND.

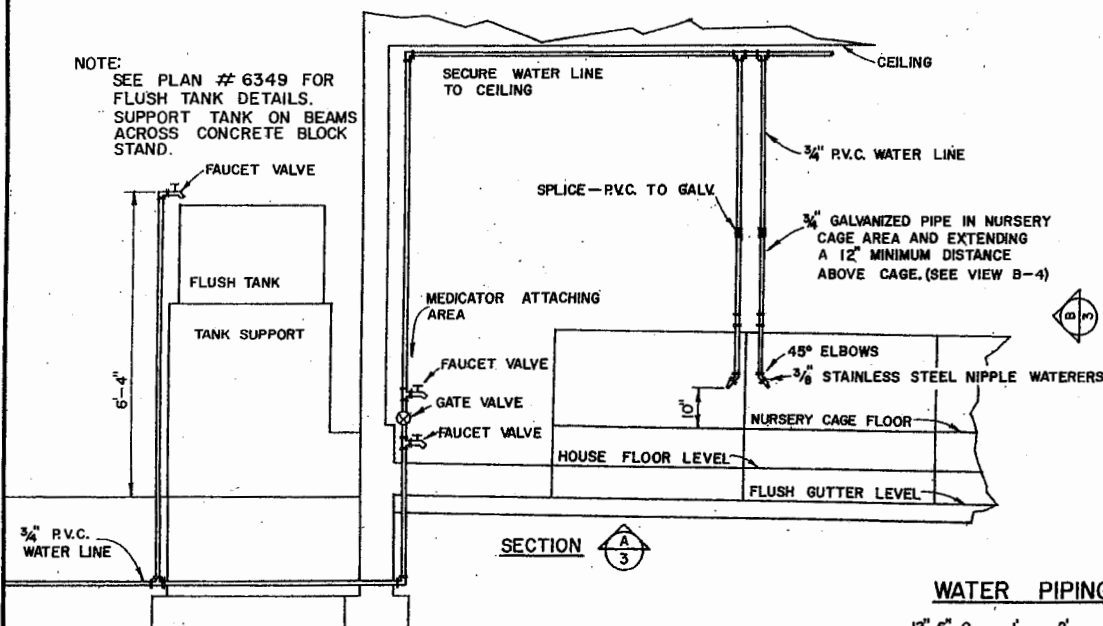


SECTION

12' 6" 0" 1' 2" SCALE 1/2"=1'-0"

WATER PIPING DETAILS

12' 6" 0" 1' 2" SCALE 1/2"=1'-0"

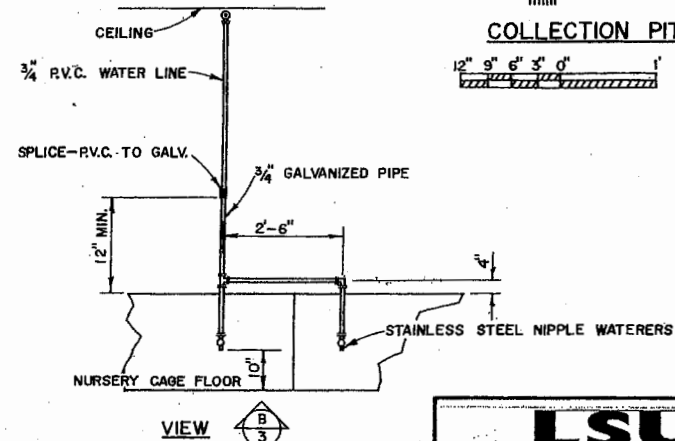

VIEW

12' 6" 0" 1' 2" SCALE 1/2"=1'-0"

LSU
AgCenter
Research & Extension

SINGLE DECK NURSERY

S.C. '82 EX. 6355 SHEET 3 OF 3

Disclaimer

This site makes available conceptual plans that can be helpful in developing building layouts and selecting equipment for various agricultural applications. These plans do not necessarily represent the most current technology or construction codes. They are not construction plans and do not replace the need for competent design assistance in developing safe, legal and well-functioning agricultural building system. The LSU Agriculture Center, the Mid-West Plan Service, the United States Department of Agriculture and none of the cooperating land-grant universities warranty these plans.