



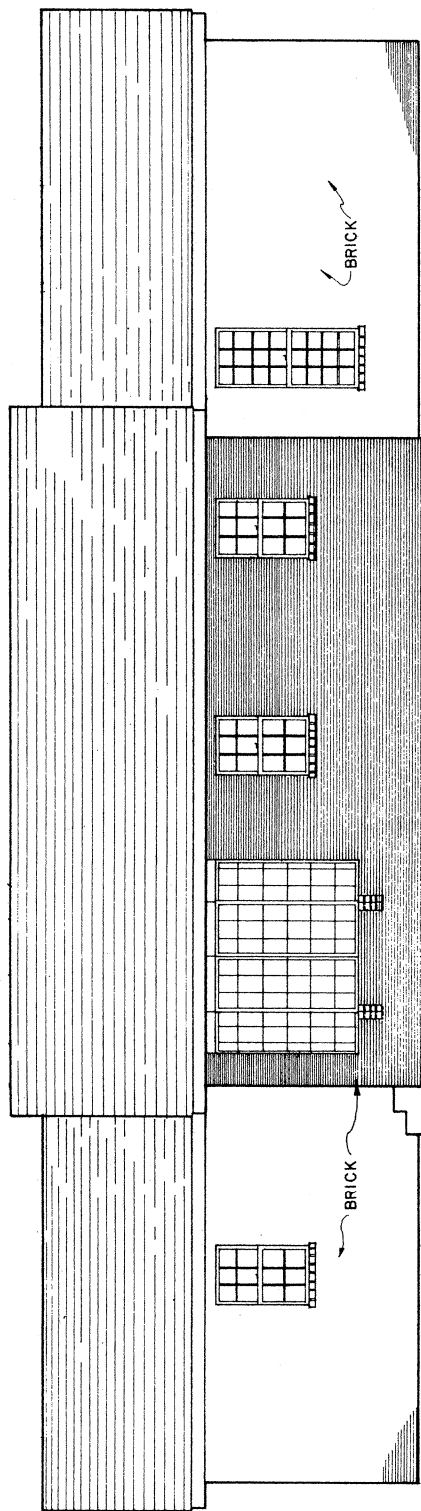

NORTH ELEVATION

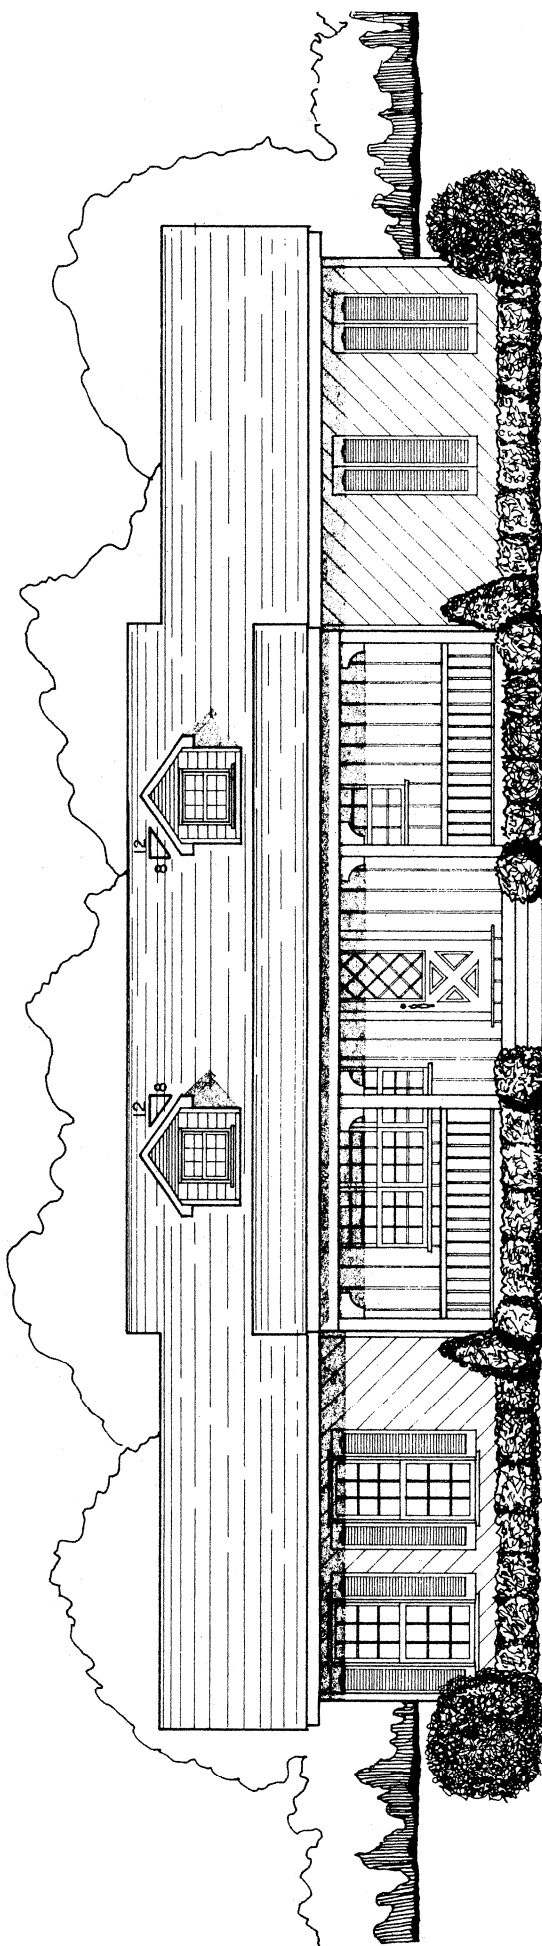

SOUTH ELEVATION



SCALE: 1/4" = 1'-0" UNLESS OTHERWISE NOTED



AFFORDABLE 2-BEDROOM COUNTRY
MISS. '81 EX. 7226 SHEET 1 OF 5




AN ENERGY EFFICIENT DESIGN

FOR OPTIMUM ENERGY EFFICIENCY
SITE WITH ROOF RIDGE EAST TO
WEST.

TOTAL SQUARE FOOTAGE — 1068

NOTE: THIS HOUSE PLAN FEATURES OPTIONAL
FUTURE EXPANSION

BASED ON: MISS. ST. UNIV. PLAN NO. 7228 A

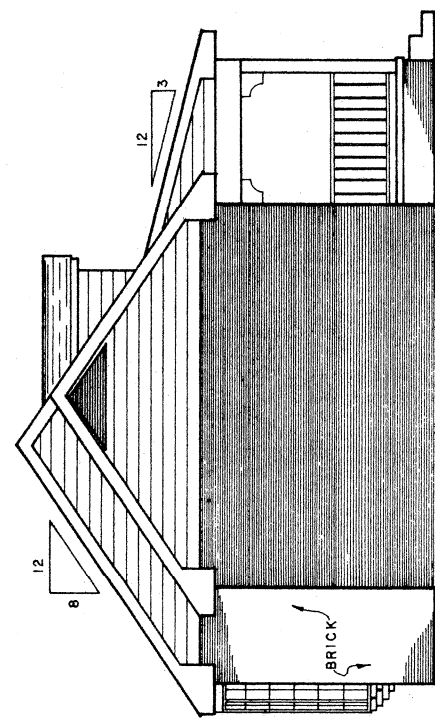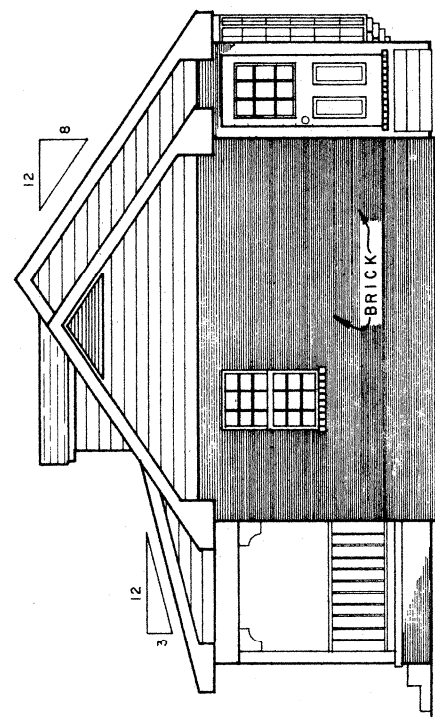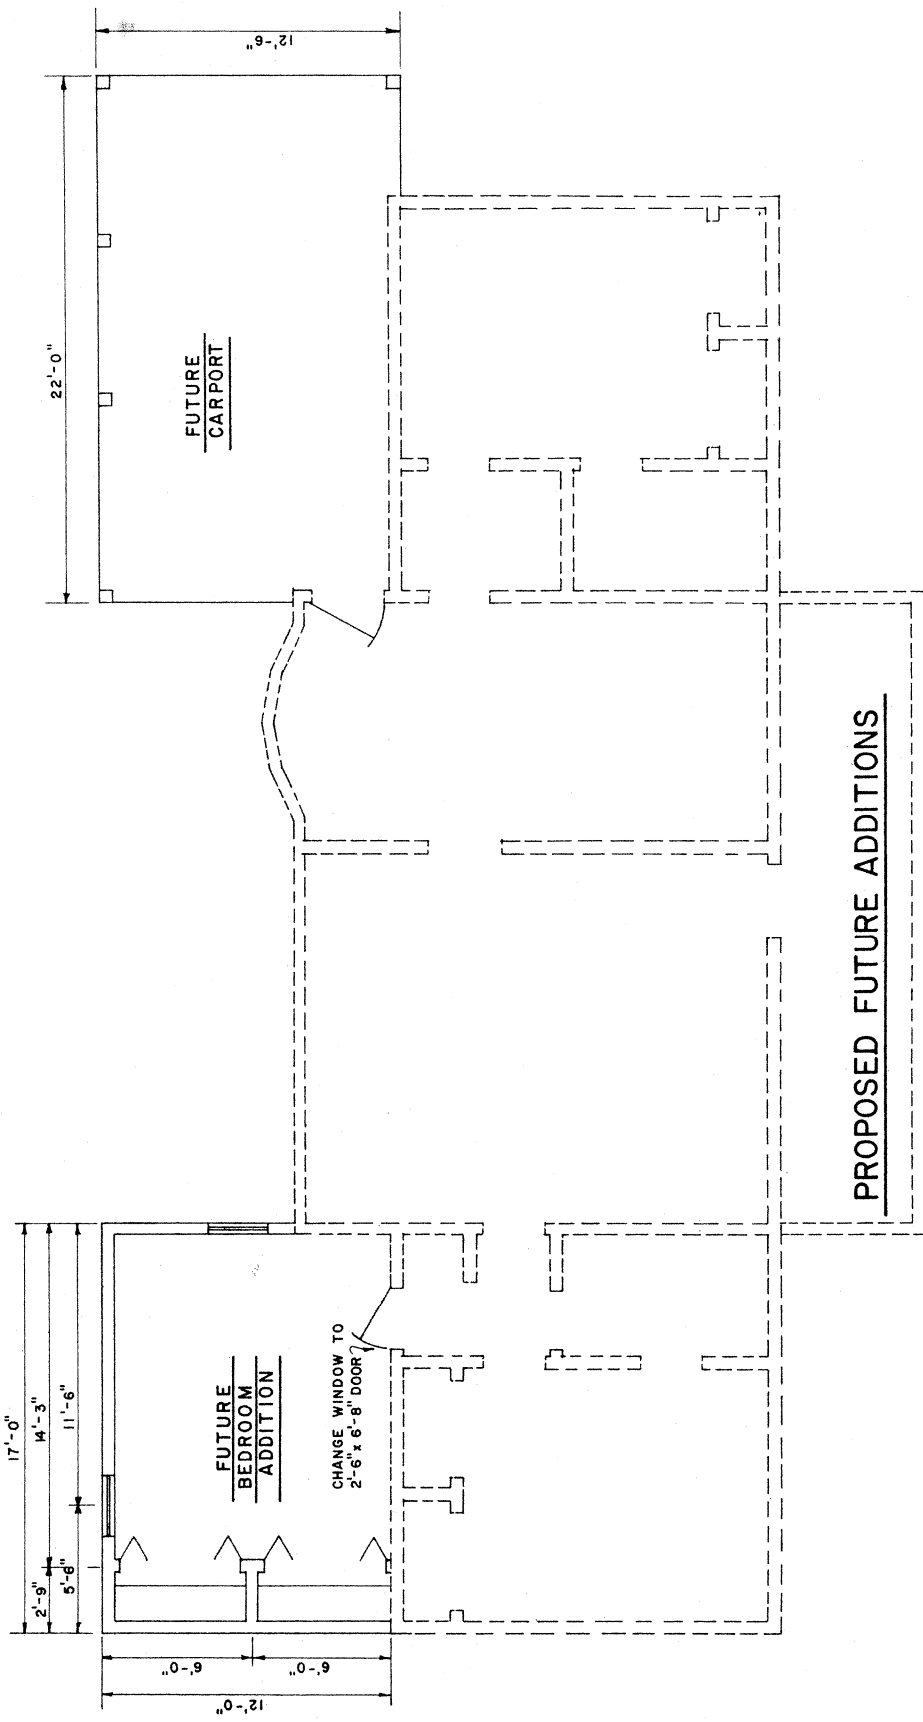

SCALE: 1/4" = 1'-0" UNLESS OTHERWISE NOTED

AFFORDABLE 2-BEDROOM COUNTRY	
MISS. '81	EX. 7226 SHEET 2 OF 5

EAST ELEVATION
SCALE: 1/4" = 1'-0"

WEST ELEVATION
SCALE: 1/4" = 1'-0"

ELECTRICAL LEGEND	
SYM.	DESCRIPTION
S	SINGLE POLE SWITCH
S ₃	THREE WAY SWITCH
S ₄	FOUR WAY SWITCH
⊕	DUPLEX 110V. OUTLET
⊕ R	RANGE OUTLET
○	SPECIAL PURPOSE OUTLET
○	LIGHTING OUTLET
○	COMB. HEAT, FAN, LIGHT
○	FLUORESCENT STRIP
○	PULL CHAIN LIGHT


WINDOW SCHEDULE		
SYM.	SIZE	DESCRIPTION
A	2'-6" x 6'-0"	SINGLE HUNG
B	2'-6" x 4'-6"	"
C	2'-6" x 3'-0"	"
D	8'-0" x 6'-0"	BOW WINDOW

NOTE: ALL WINDOWS SHALL BE CERTIFIED INSULATED ALUMINUM FRAME WITH BRONZE ENAMEL FINISH.

DOOR SCHEDULE		
SYM.	SIZE	DESCRIPTION
①	3'-0" x 6'-8"	STEEL CLAD EXTERIOR
②	2'-6" x 6'-8"	INTERIOR PANEL
③	4'-0" x 6'-8"	DOUBLE BI-FOLD
④	2'-6" x 6'-8"	INTERIOR POCKET
⑤	3'-0" x 7'-0"	FRAMED OPENING

NOTE: ALL EXTERIOR DOORS SHALL BE STEEL CLAD WITH INSULATED CORE.

NOTE: DOOR TRIM & HARDWARE TO BE SELECTED BY OWNER



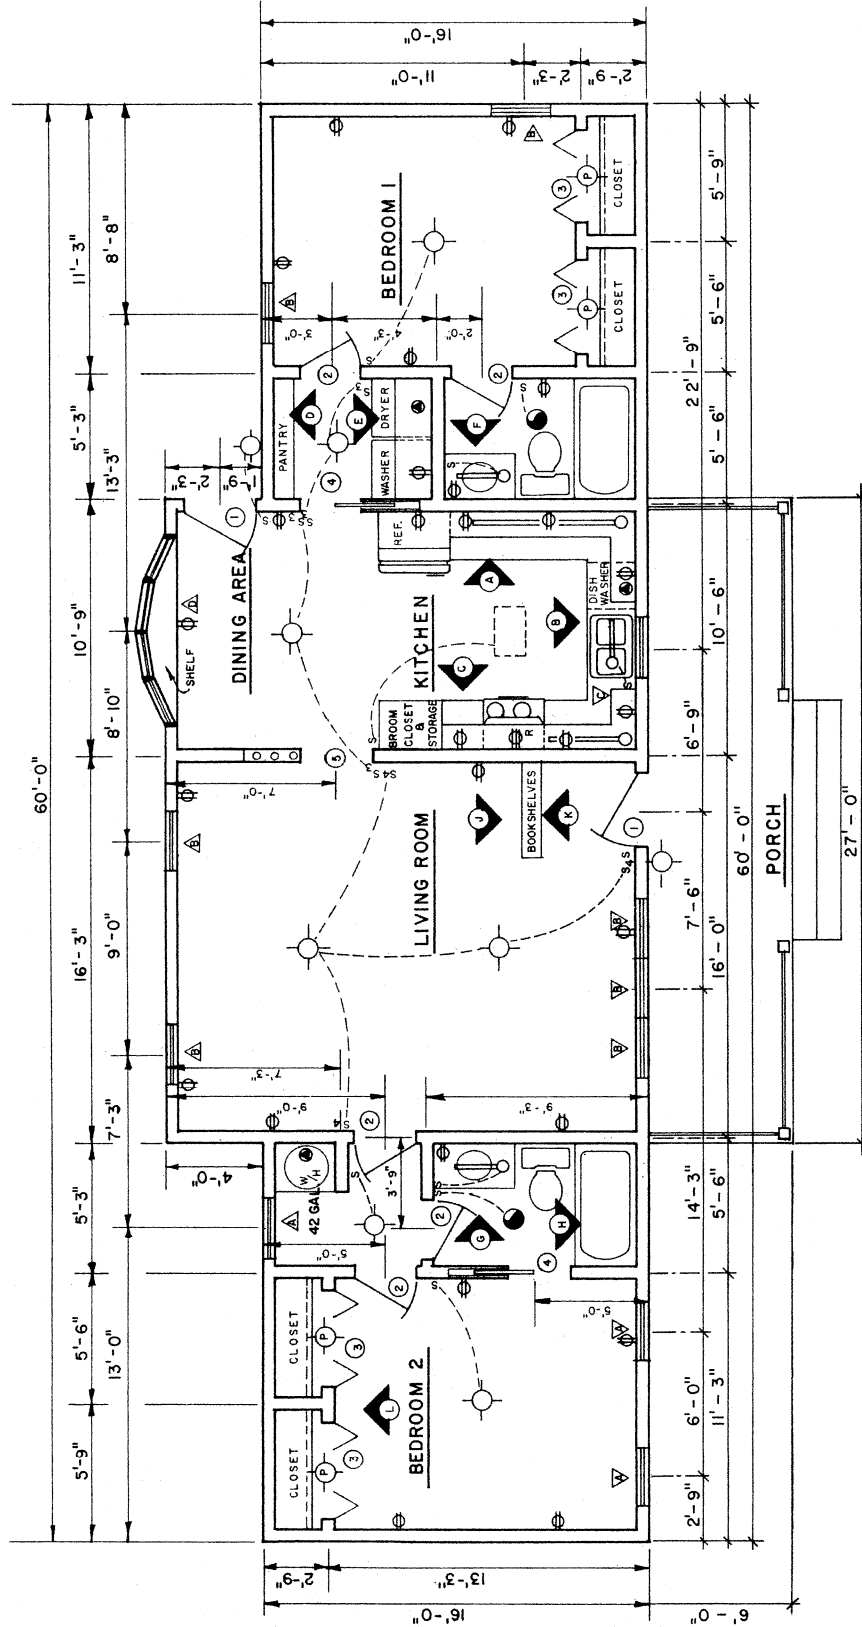


FLOOR PLAN
SCALE: 1/4" = 1'-0"



SCALE: 1/4" = 1'-0" UNLESS OTHERWISE NOTED







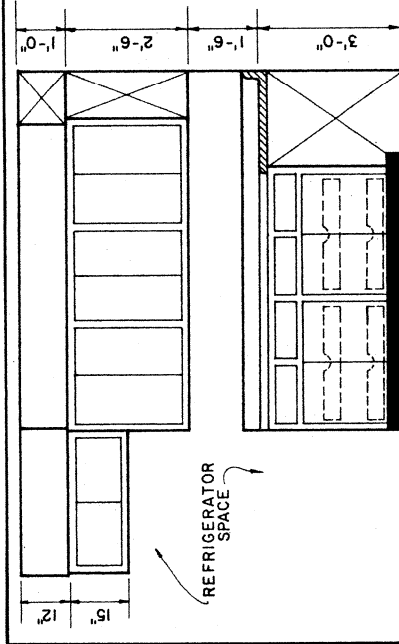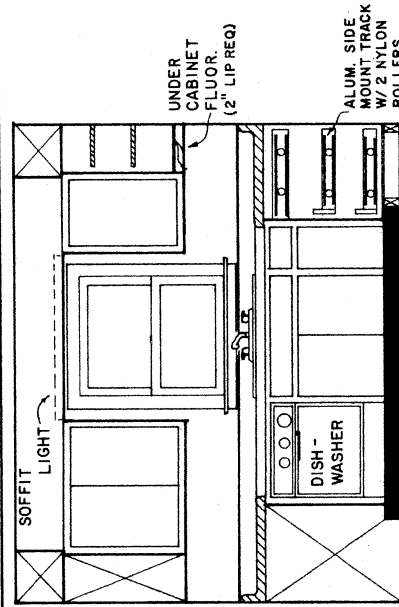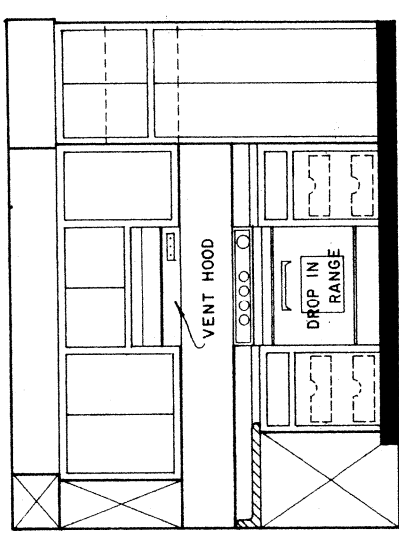

C

B

A

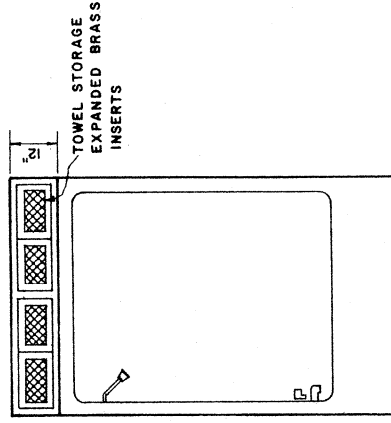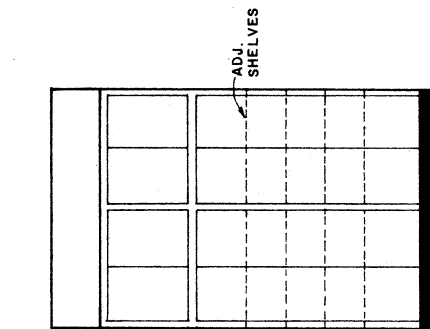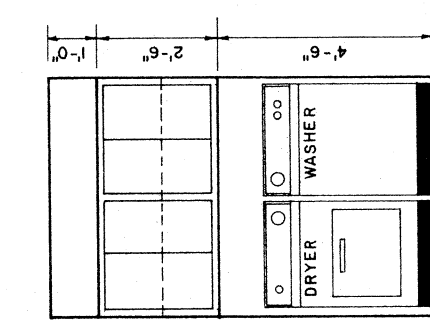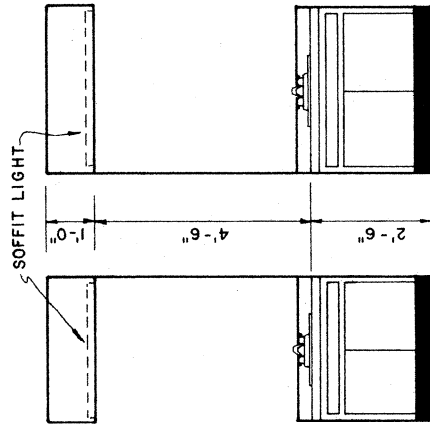






H

G

F


E

D

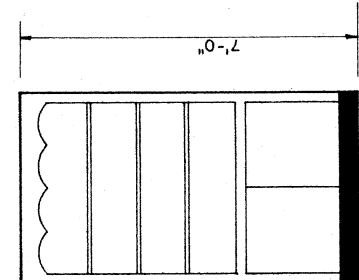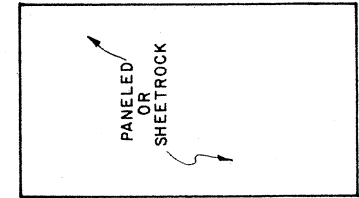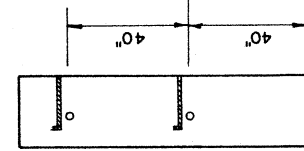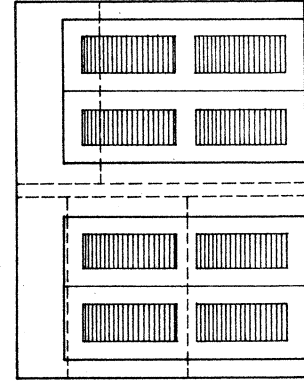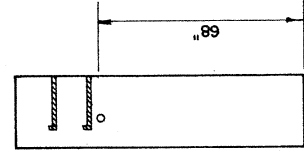

TYP. CLOSET ARRANGEMENT

 SCALE: 3/8" = 1'-0"



SCALE: 1/2" = 1'-0"



SCALE: 1/2" = 1'-0" UNLESS OTHERWISE NOTED





CABINET ELEVATIONS

SCALE: 1/2" = 1'-0"

MISS. '81 EX. 7226 SHEET 4 OF 5

 AFFORDABLE 2-BEDROOM COUNTRY

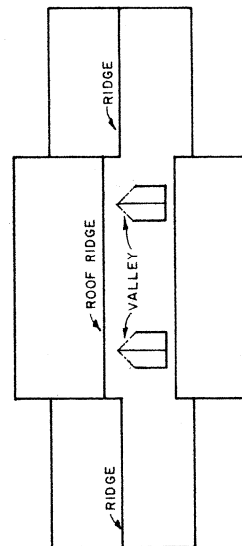


ROOF PLAN
NO SCALE



SCALE: 1/8" = 1'-0" UNLESS OTHERWISE NOTED



 WALL SECTION



AFFORDABLE 2-BEDROOM COUNTRY

MISS. '81	EX. 7226	SHEET 5 OF 5
-----------	----------	--------------